

ALLCOM



GLOBAL SERVICES

NEW DATA CENTER CONSTRUCTION PROJECT

14 SELF BOULEVARD, CARTERET, NEW JERSEY

Block: 64.02 Lot: 6.08

LIST OF DRAWINGS	
C-1	COVER PAGE
	EXISTING CONDITIONS PLAN
	SITE PLAN
A-1	DEMOLITION PLAN
A-2	CONSTRUCTION FLOOR PLAN
A-3	TOILET PLANS, DOOR SCHEDULE, FINISH SCHEDULE
A-4	REFLECTED CEILING PLAN
A-5	BUILDING SECTIONS
A-6	WALL TYPES, DETAILS AND SECTIONS
A-7	ROOF PLAN, DETAILS
A-8	GENERAL NOTES
E-1	ELECTRICAL SITE & MAIN ROOM PLAN
E-1-1	GENERATORS ELEVATIONS PLAN
E-1-2	GENERATORS INSTALLATION DETAILS PLAN
E-2	RISER DIAGRAM PLAN
E-3	ELECTRICAL DEMOLITION PLAN
E-4	ELECTRICAL POWER PLAN
E-5	LIGHTING PLAN
E-6	PANEL SCHEDULES & DETAILS PLAN
E-7	GROUNDING SYSTEM PLAN
E-8	LEGEND AND SPECIFICATIONS
E-9	ELECTRICAL SPECIFICATIONS (1 OF 3)
E-10	ELECTRICAL SPECIFICATIONS (2 OF 3)
E-11	ELECTRICAL SPECIFICATIONS (3 OF 3)
MD-1	EXISTING LAYOUT & MECHANICAL DEMOLITION FOR NG-PIPING & HVAC EQUIPMENT
M-1	LAYOUT FOR CHILLERS ON ROOF & EQUIPMENT DETAILS
M-2	AIR CONDITIONING UNITS LAYOUT & HOT-COLD AISLES IN DATA CENTER & RECTIFIER ROOM
M-3	ELEVATION VIEWS FOR CHILLER INSTALLATION & INSIDE BUILDING
M-4	CHILLED WATER PIPING LAYOUT AT ROOF
M-5	CHILLED WATER PIPING LAYOUT INSIDE BUILDING
M-6	ONE-LINE DIAGRAM FOR CHILLED WATER PIPING
M-7	OFFICE SPACE DUCTWORK LAYOUT, ELEVATION & ONE-LINE DIAGRAM
M-8	RAISED FLOOR PERFORATED TILES & CEILING RETURN GRILLES LAYOUT IN DATA CENTER
M-9	WATER SUPPLY PIPING LAYOUT & ONE-LINE DIAGRAM FOR DATA CENTER
M-10	CONDENSATE DRAIN PIPING LAYOUT & ONE-LINE DIAGRAM FOR DATA CENTER
M-11	MECHANICAL EQUIPMENT SCHEDULES
M-12	MECHANICAL DETAILS
M-13	MECHANICAL SYMBOLS & ABBREVIATIONS
M-14	MECHANICAL SPECIFICATIONS (1/3)
M-15	MECHANICAL SPECIFICATIONS (2/3)
M-16	MECHANICAL SPECIFICATIONS (3/3)
P-1	EXISTING PIPING LAYOUT, DEMOLITION & NEW PIPING PLAN
P-1	SANITARY & WATER RISER DIAGRAMS, DETAIL & SPECIFICATIONS
S-1	STRUCTURAL PLAN & DETAILS FOR ROOF STRUCTURE
SP-1	FIRE SPRINKLER SYSTEM

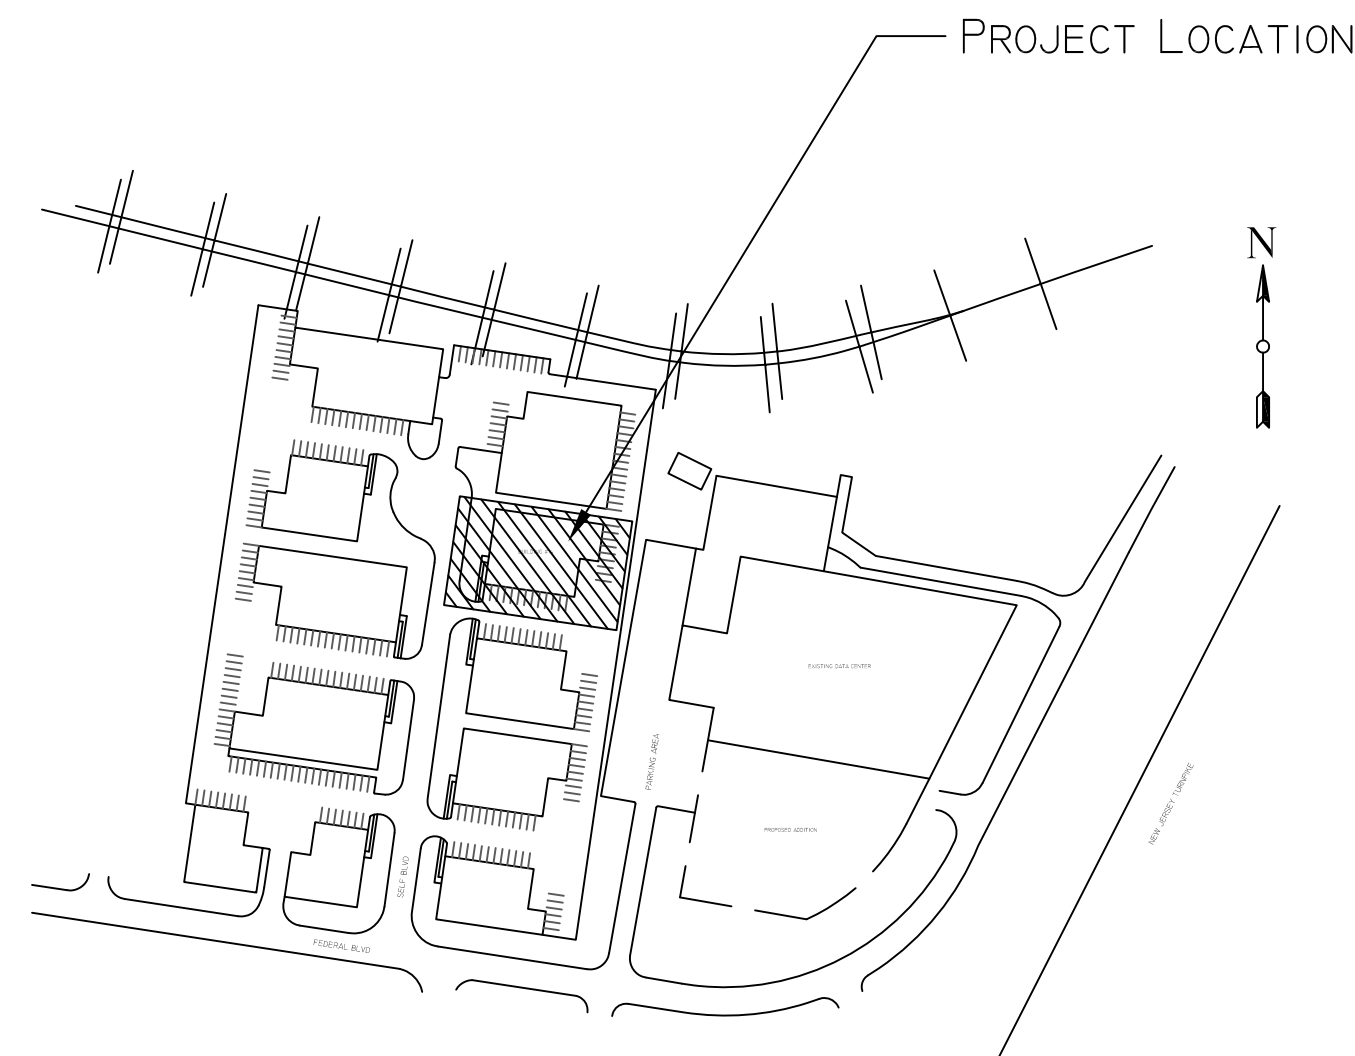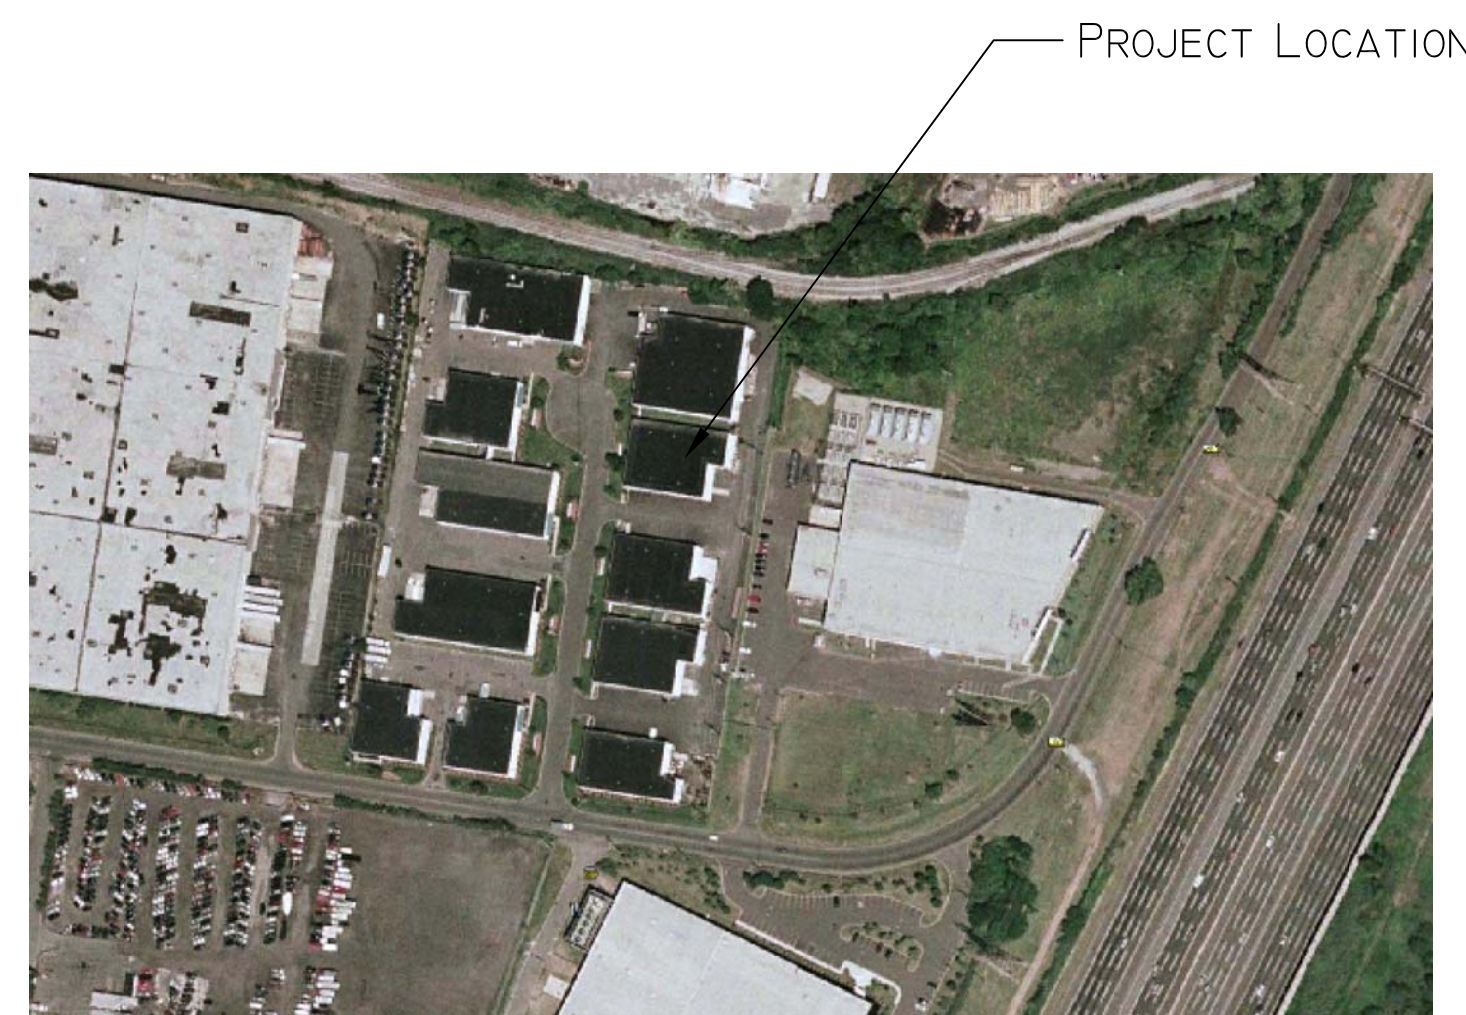

LTR	DATE	REVISION DESCRIPTION	BY
-	04/12/10	Issued For Permit	AG



AllCom Global Services, Inc.
201 Stag Industrial Blvd., Lake St. Louis, MO 63367
Phone: 512-328-2451 [P] 636.625.1717 [F] 636.625.6177



5524 Bee Caves Rd., Suite C-1, Austin, TX 78746
Phone: 512-328-2451
web: www.catvdesgn.com



MGI NETWORK SERVICES, LLC.
2800 Longhorn Blvd., Suite 101, Austin, TX 78758
Tel: 512-795-8055 Fax: 512-491-7657
web: www.mginetworkservices.com



185 Ridgedale Avenue, Cedar Knolls, NJ 07927
Tel: 973-889-1101 Fax: 973-889-1170
e-mail: sa@sullivanusa.com



T. M. RYBAK AND ASSOCIATES P. C.
15 WEST ERIE AVENUE
RUTHERFORD, NEW JERSEY 07070
201-460-0473 FAX 201-460-0931
ARCHITECTS-INTERIOR DESIGNERS-ENGINEERS

LICENSE NUMBERS:
NJ AJ 09829
CA 008485
CO 019857-1
CT 0902300
IL 1301040380
IN 001-019551
PA PA-010849-B
NH 3576
MD 7823
KS 4533
MA 8687
NC 8441
CT 07884
TX 14895
MN 26586
MO 007521

AKIN GOGUS
PROFESSIONAL ENGINEER
NJ GE048363

Project Name:
CARTERET DATA CENTER
14 Self Blvd., Carteret, NJ

Drawing Title:
Cover Page

Drawn By:
A.G.
Checked By:
R.J.S.
Scale:
N.T.S.
Date:
04/05/2010

Project No.
Q10421-ALC

Drawing No.
C-1