


UNDER RAISED FLOOR (UP TO UNITS)

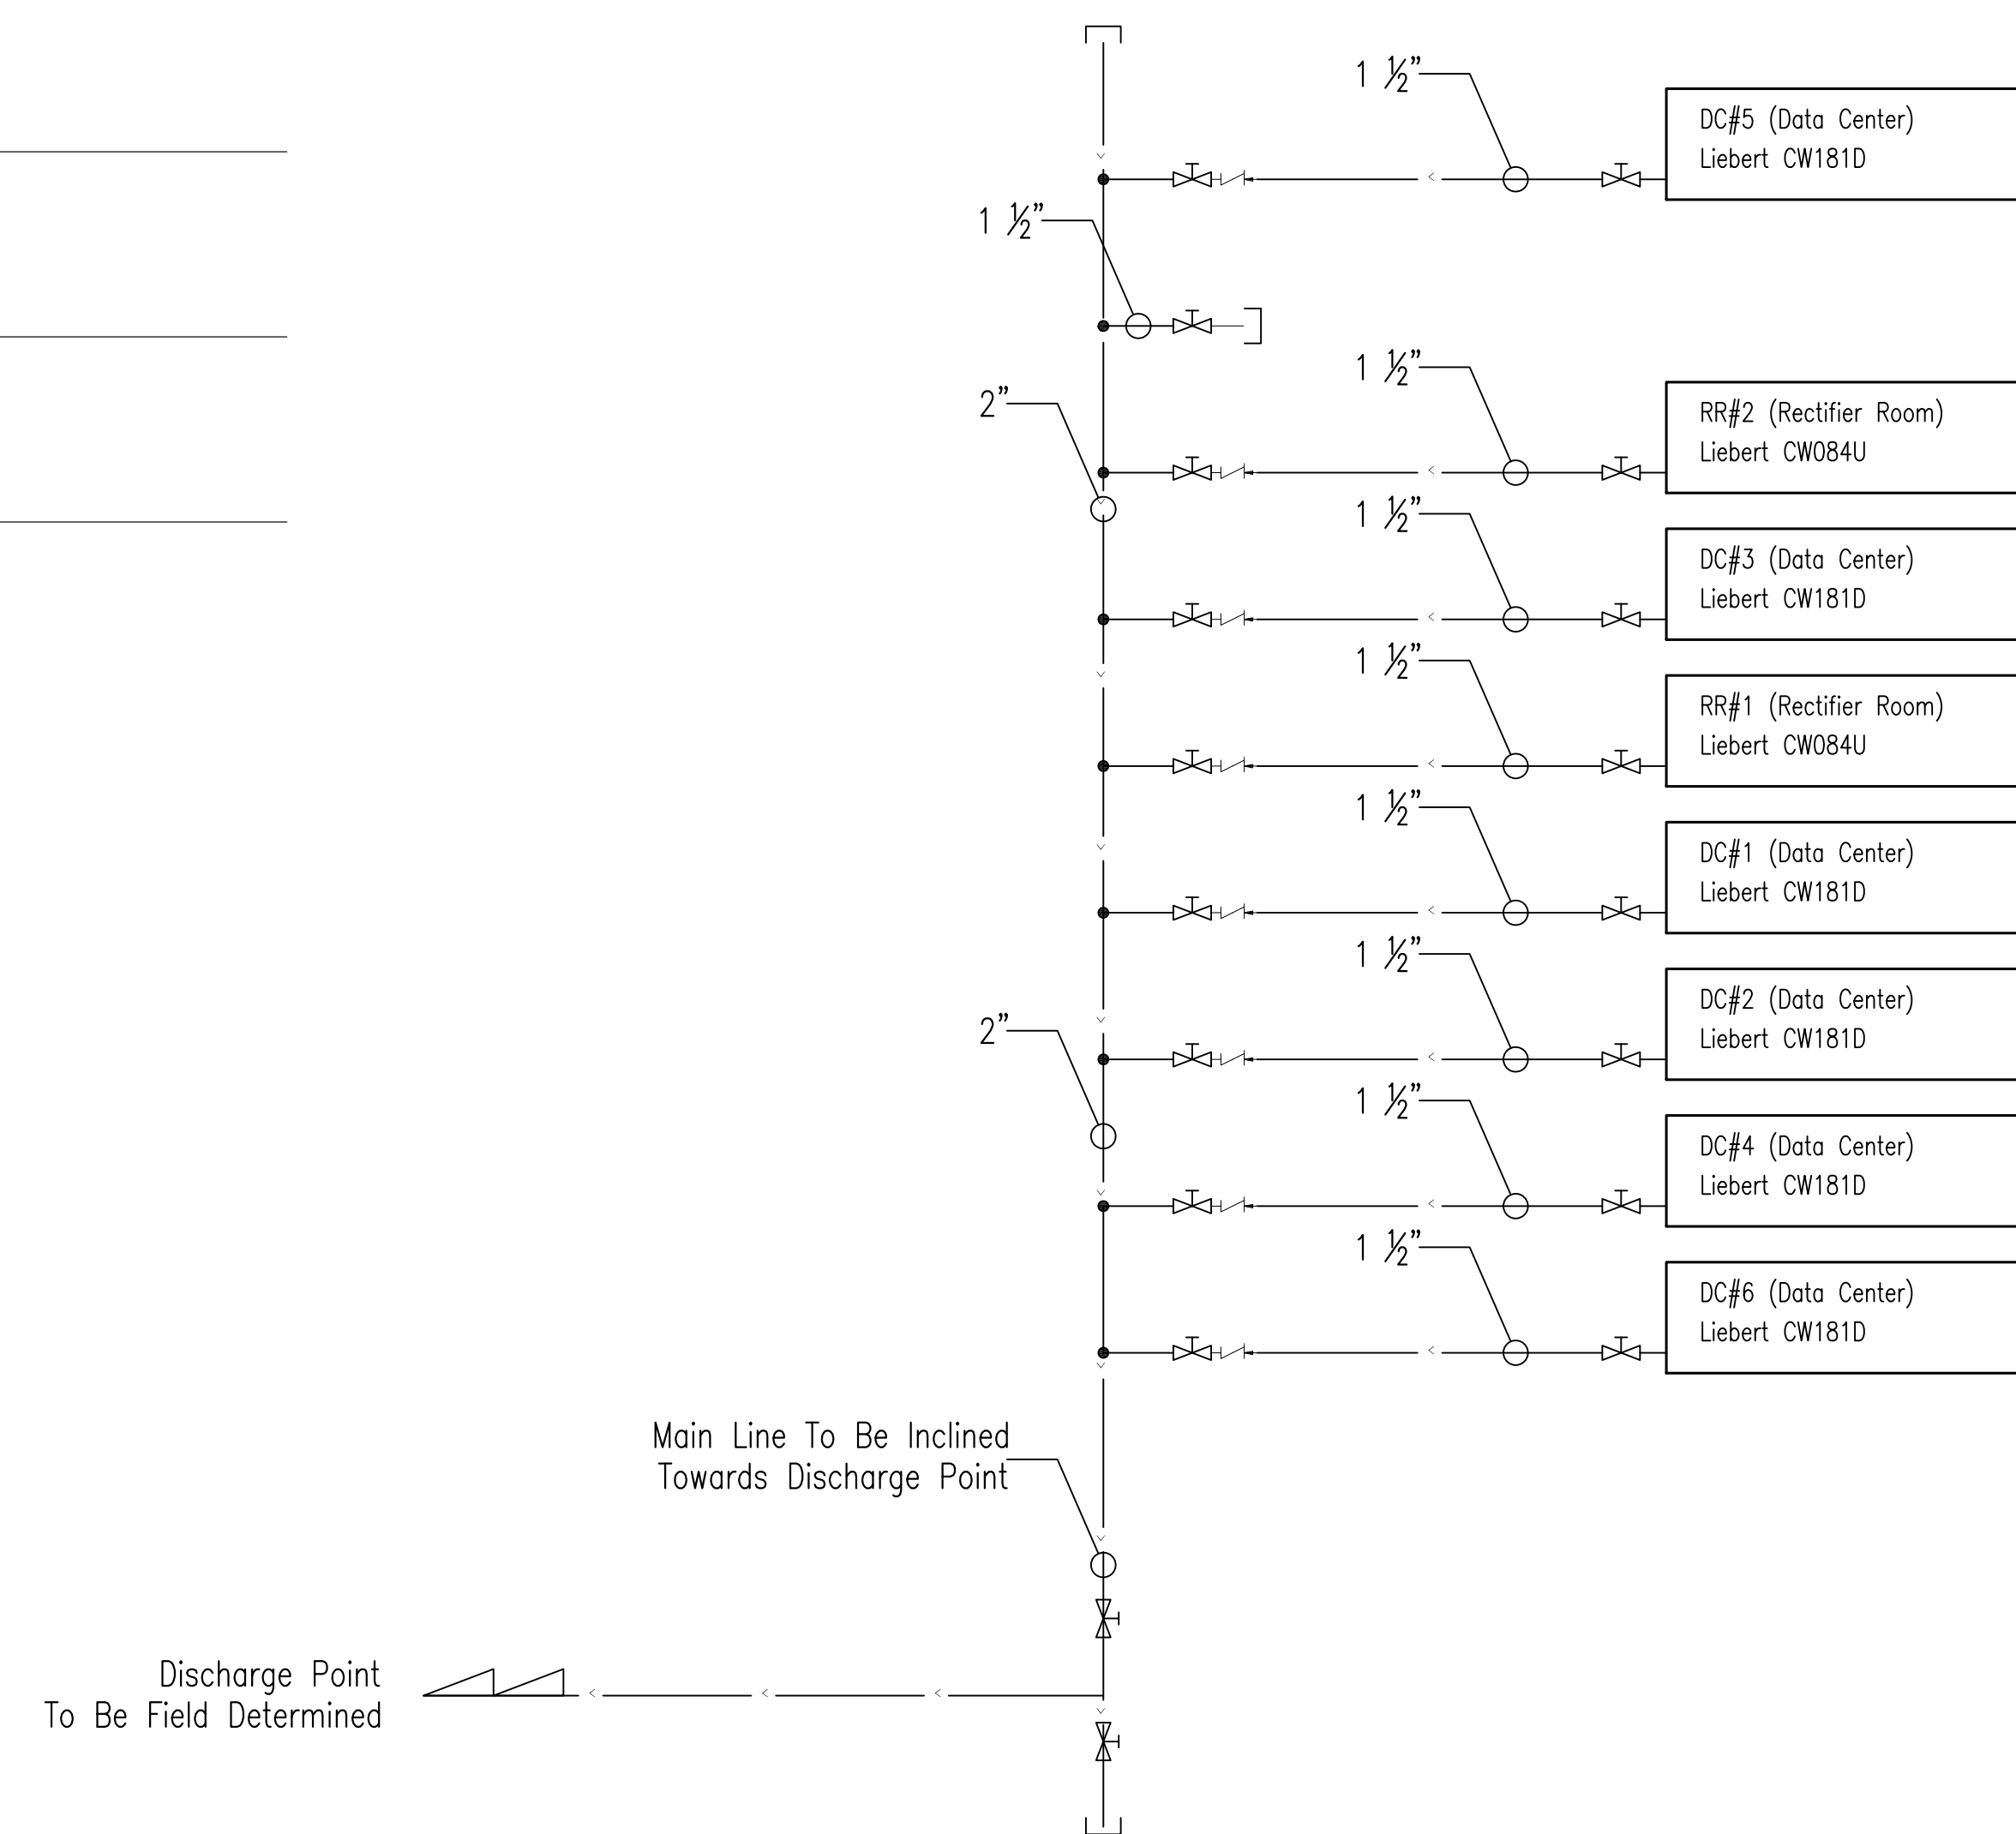

One-Line Diagram For Data Center Condensate Drain Piping

SCALE: Not To Scale

Condensate Drain Piping Layout

SCALE: 1/8"=1'-0"

LTR	DATE	REVISION DESCRIPTION	BY
-	04/12/10	Issued For Permit	AG



AllCom Global Services, Inc.
201 Stag Industrial Blvd., Lake St. Louis, MO 63367
[P] 636.625.1717 [F] 636.625.6177
www.allcomge.com



5524 Bee Caves Rd., Suite C-1, Austin, TX 78746
Phone: 512-328-2461
www.catvdesign.com



MGI NETWORK SERVICES, LLC.
2800 Longhorn Blvd., Suite 101, Austin, TX 78758
Tel: 512-795-9055 Fax: 512-491-7657
web: www.mginetworkservices.com



185 Ridgedale Avenue, Cedar Knolls, NJ 07927
Tel: 973-889-1101 Fax: 973-889-1170
e-mail: sa@sullivanusa.com

AKIN GOGUS
PROFESSIONAL ENGINEER

NJ GE048363

Project Name:

CARTERET DATA CENTER
14 Self Blvd., Carteret, NJ

Drawing Title:

Condensate Drain Piping
Layout & One-Line
Diagram For Data Center

Drawn By:
A.G.
Checked By:
R.J.S.
Scale:
As Noted
Date:
04/05/2010

Project No.
Q10421-ALC

Drawing No.
M - 10